


25580

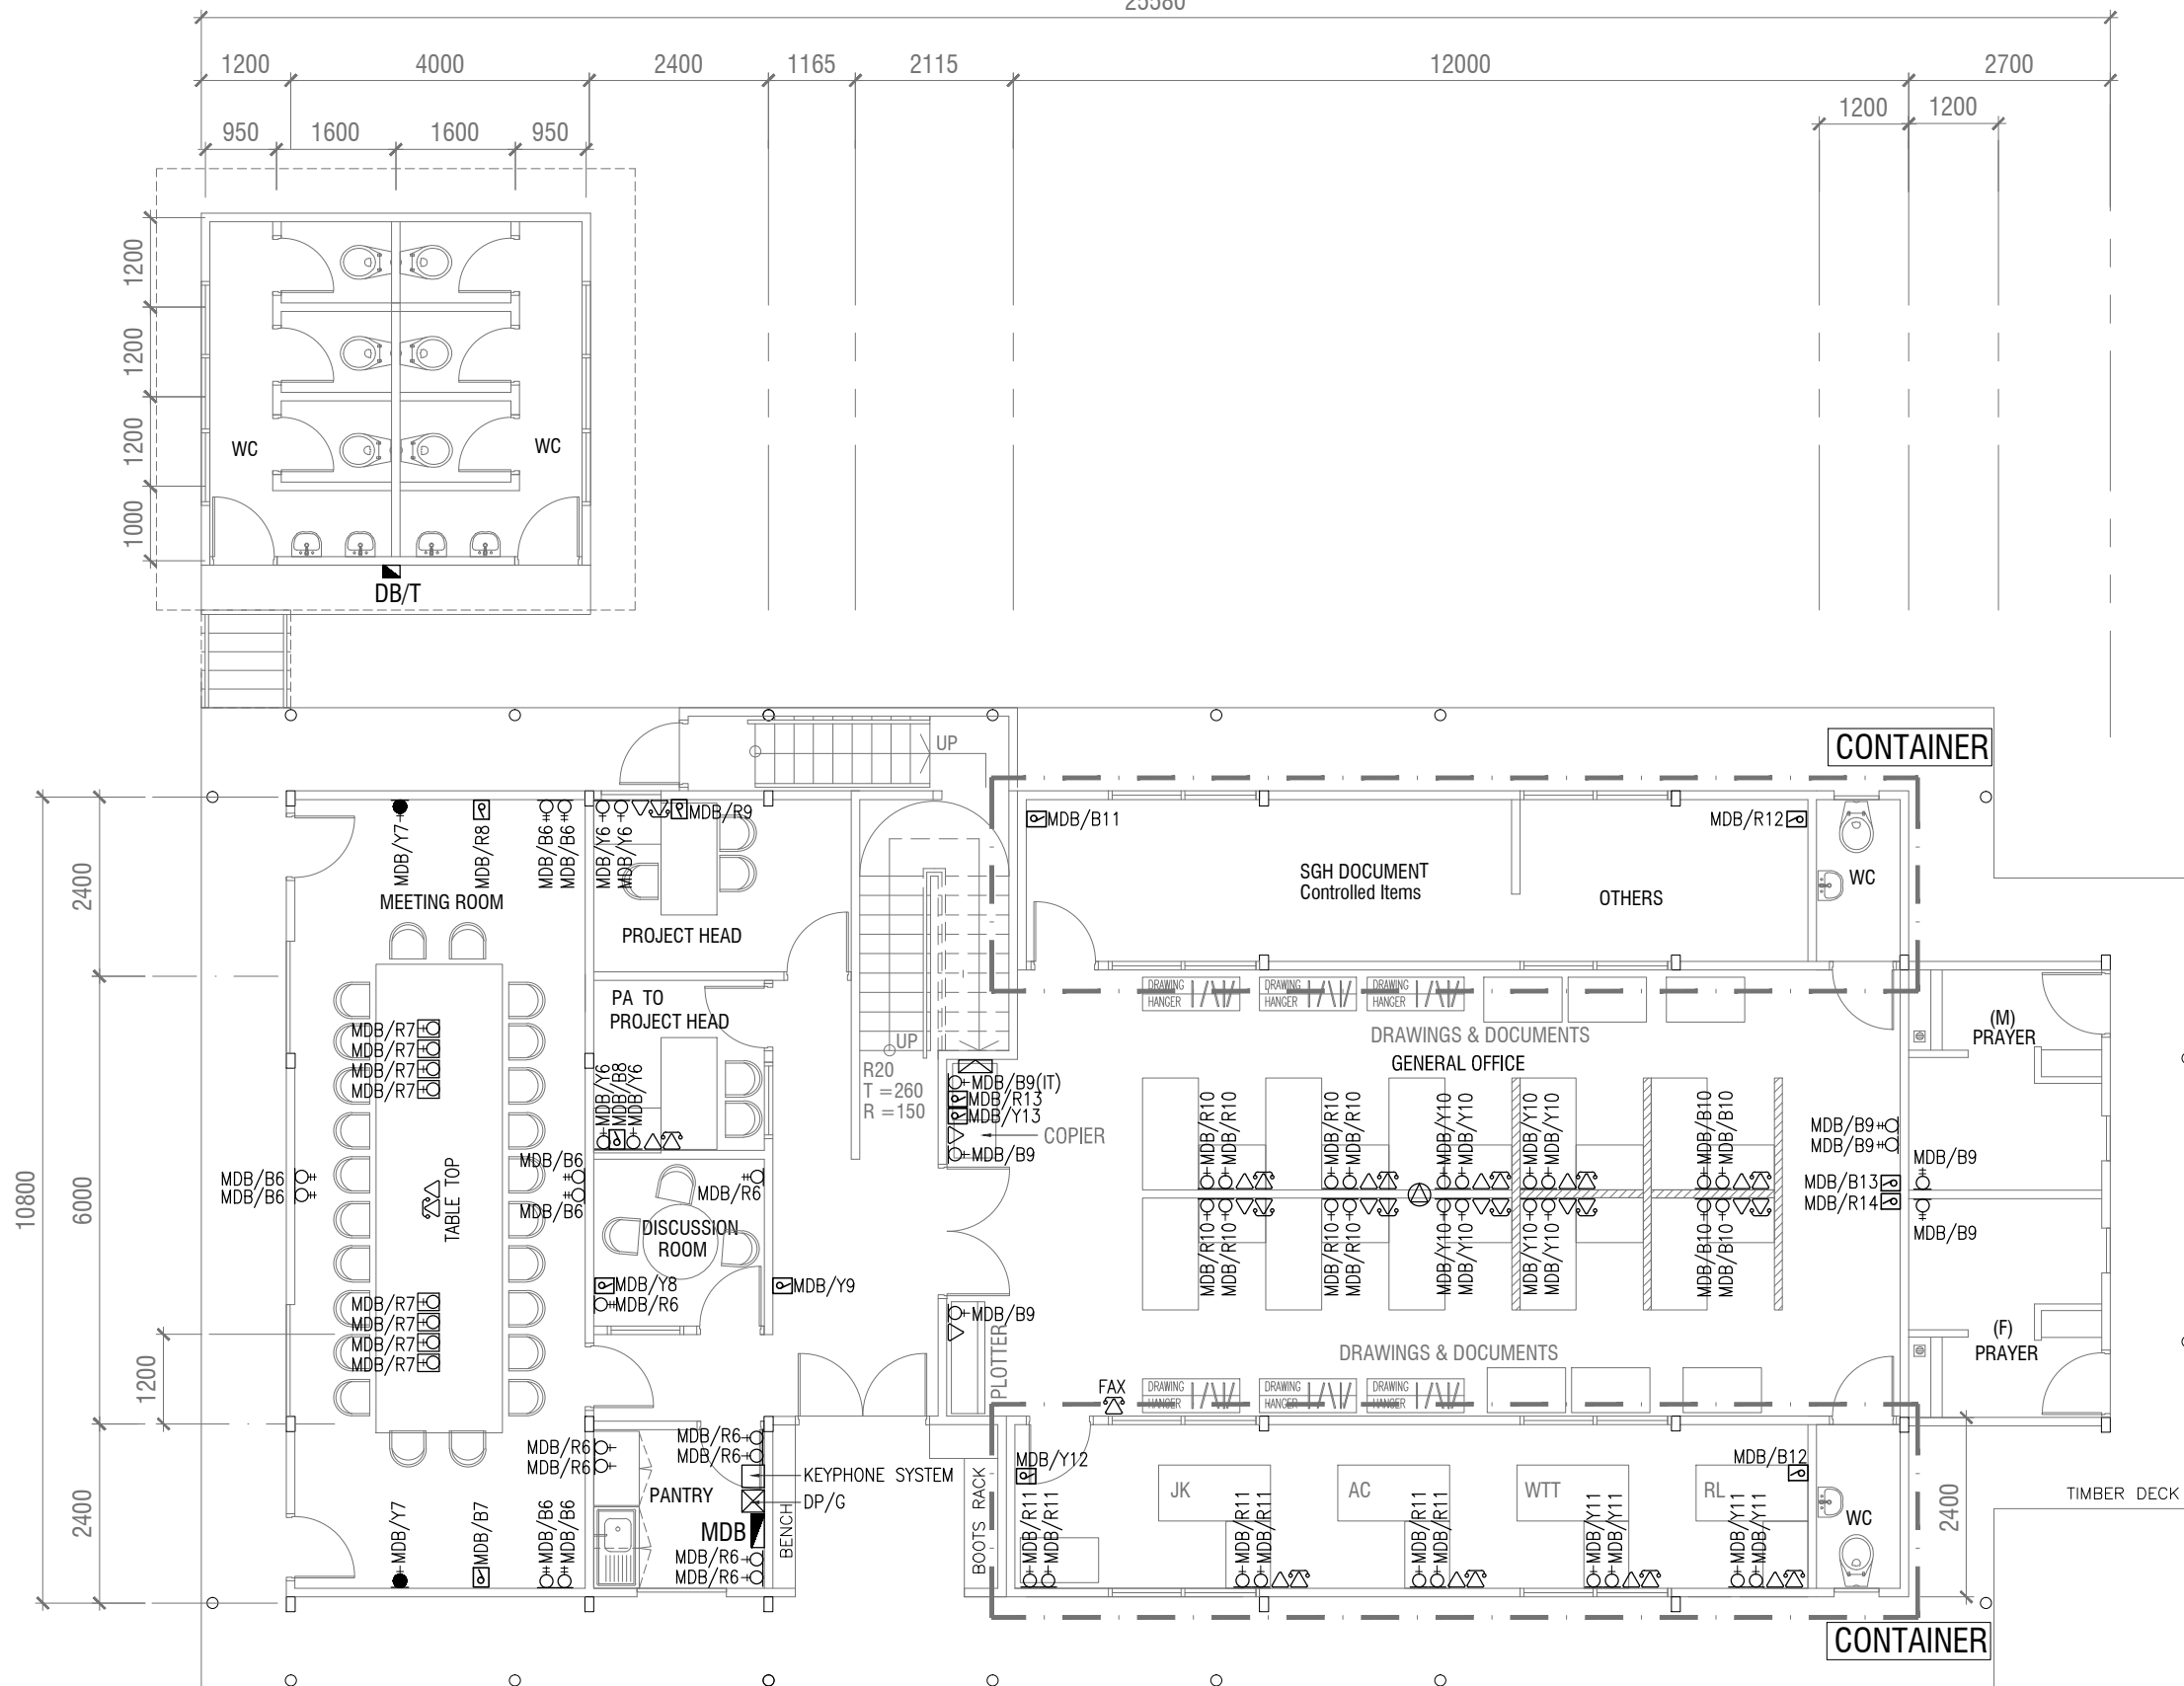

**GROUND FLOOR PLAN**  
SCALE 1 : 100

LEGEND  
 PARTITION

THIS DRAWING IS COPYRIGHT  
 NOTE : This drawing and the information herein is protected by COPYRIGHT. No part or whole can be copied or reproduced in any form without written consent from ARKITEK KSI SDN BHD. Contractor shall check all dimensions in this drawing before commencement of work and is responsible for correct setting-up of site. Figures/Dimensions shall be taken in preference to scale dimension. In the event of any discrepancy arising from this drawing, contractor should notify the architect before commencement of work. All drawings must be read in conjunction with other consultant's drawing.



**GOVERNMENT OF MALAYSIA**  
**KEMENTERIAN KESIHATAN MALAYSIA**

Persim 1, Aras 12, Blok E7, Parcel E,  
 Pusat Perubatan Kerajaan Persekutuan,  
 62500 Wilayah Persekutuan, Putrajaya.

PROJECT:  
**CADANGAN MENAIKARAF HOSPITAL UMUM SARAWAK SECARA PUBLIC PRIVATE PARTNERSHIP- BLMT MELALUI PEROLEHAN SECARA 'SWISS CHALLENGE'**

PFI PROPOSER:  
**ASALJURU WEIDA SDN BHD**  
 1st FLOOR, LOT 10146, KUALA  
 LAMPANG LEE SIANG 33450, KUCHING  
 TEL: 082-330875 FAX: 082-334875

Drawing Title :	
<b>ELECTRICAL SERVICES POWER LAYOUT GROUND FLOOR PLAN</b>	
Scale : 1:100	Date : MAY 2017
Drawn by : MW	Designed by : WTT
Checked by : WTT	Approved by : -
Drawing No. : <b>SGH/SO/ELEC/04</b>	